


- ① Pipes are below the reflected ceiling.
- ② Hvac Pipes are exposed.

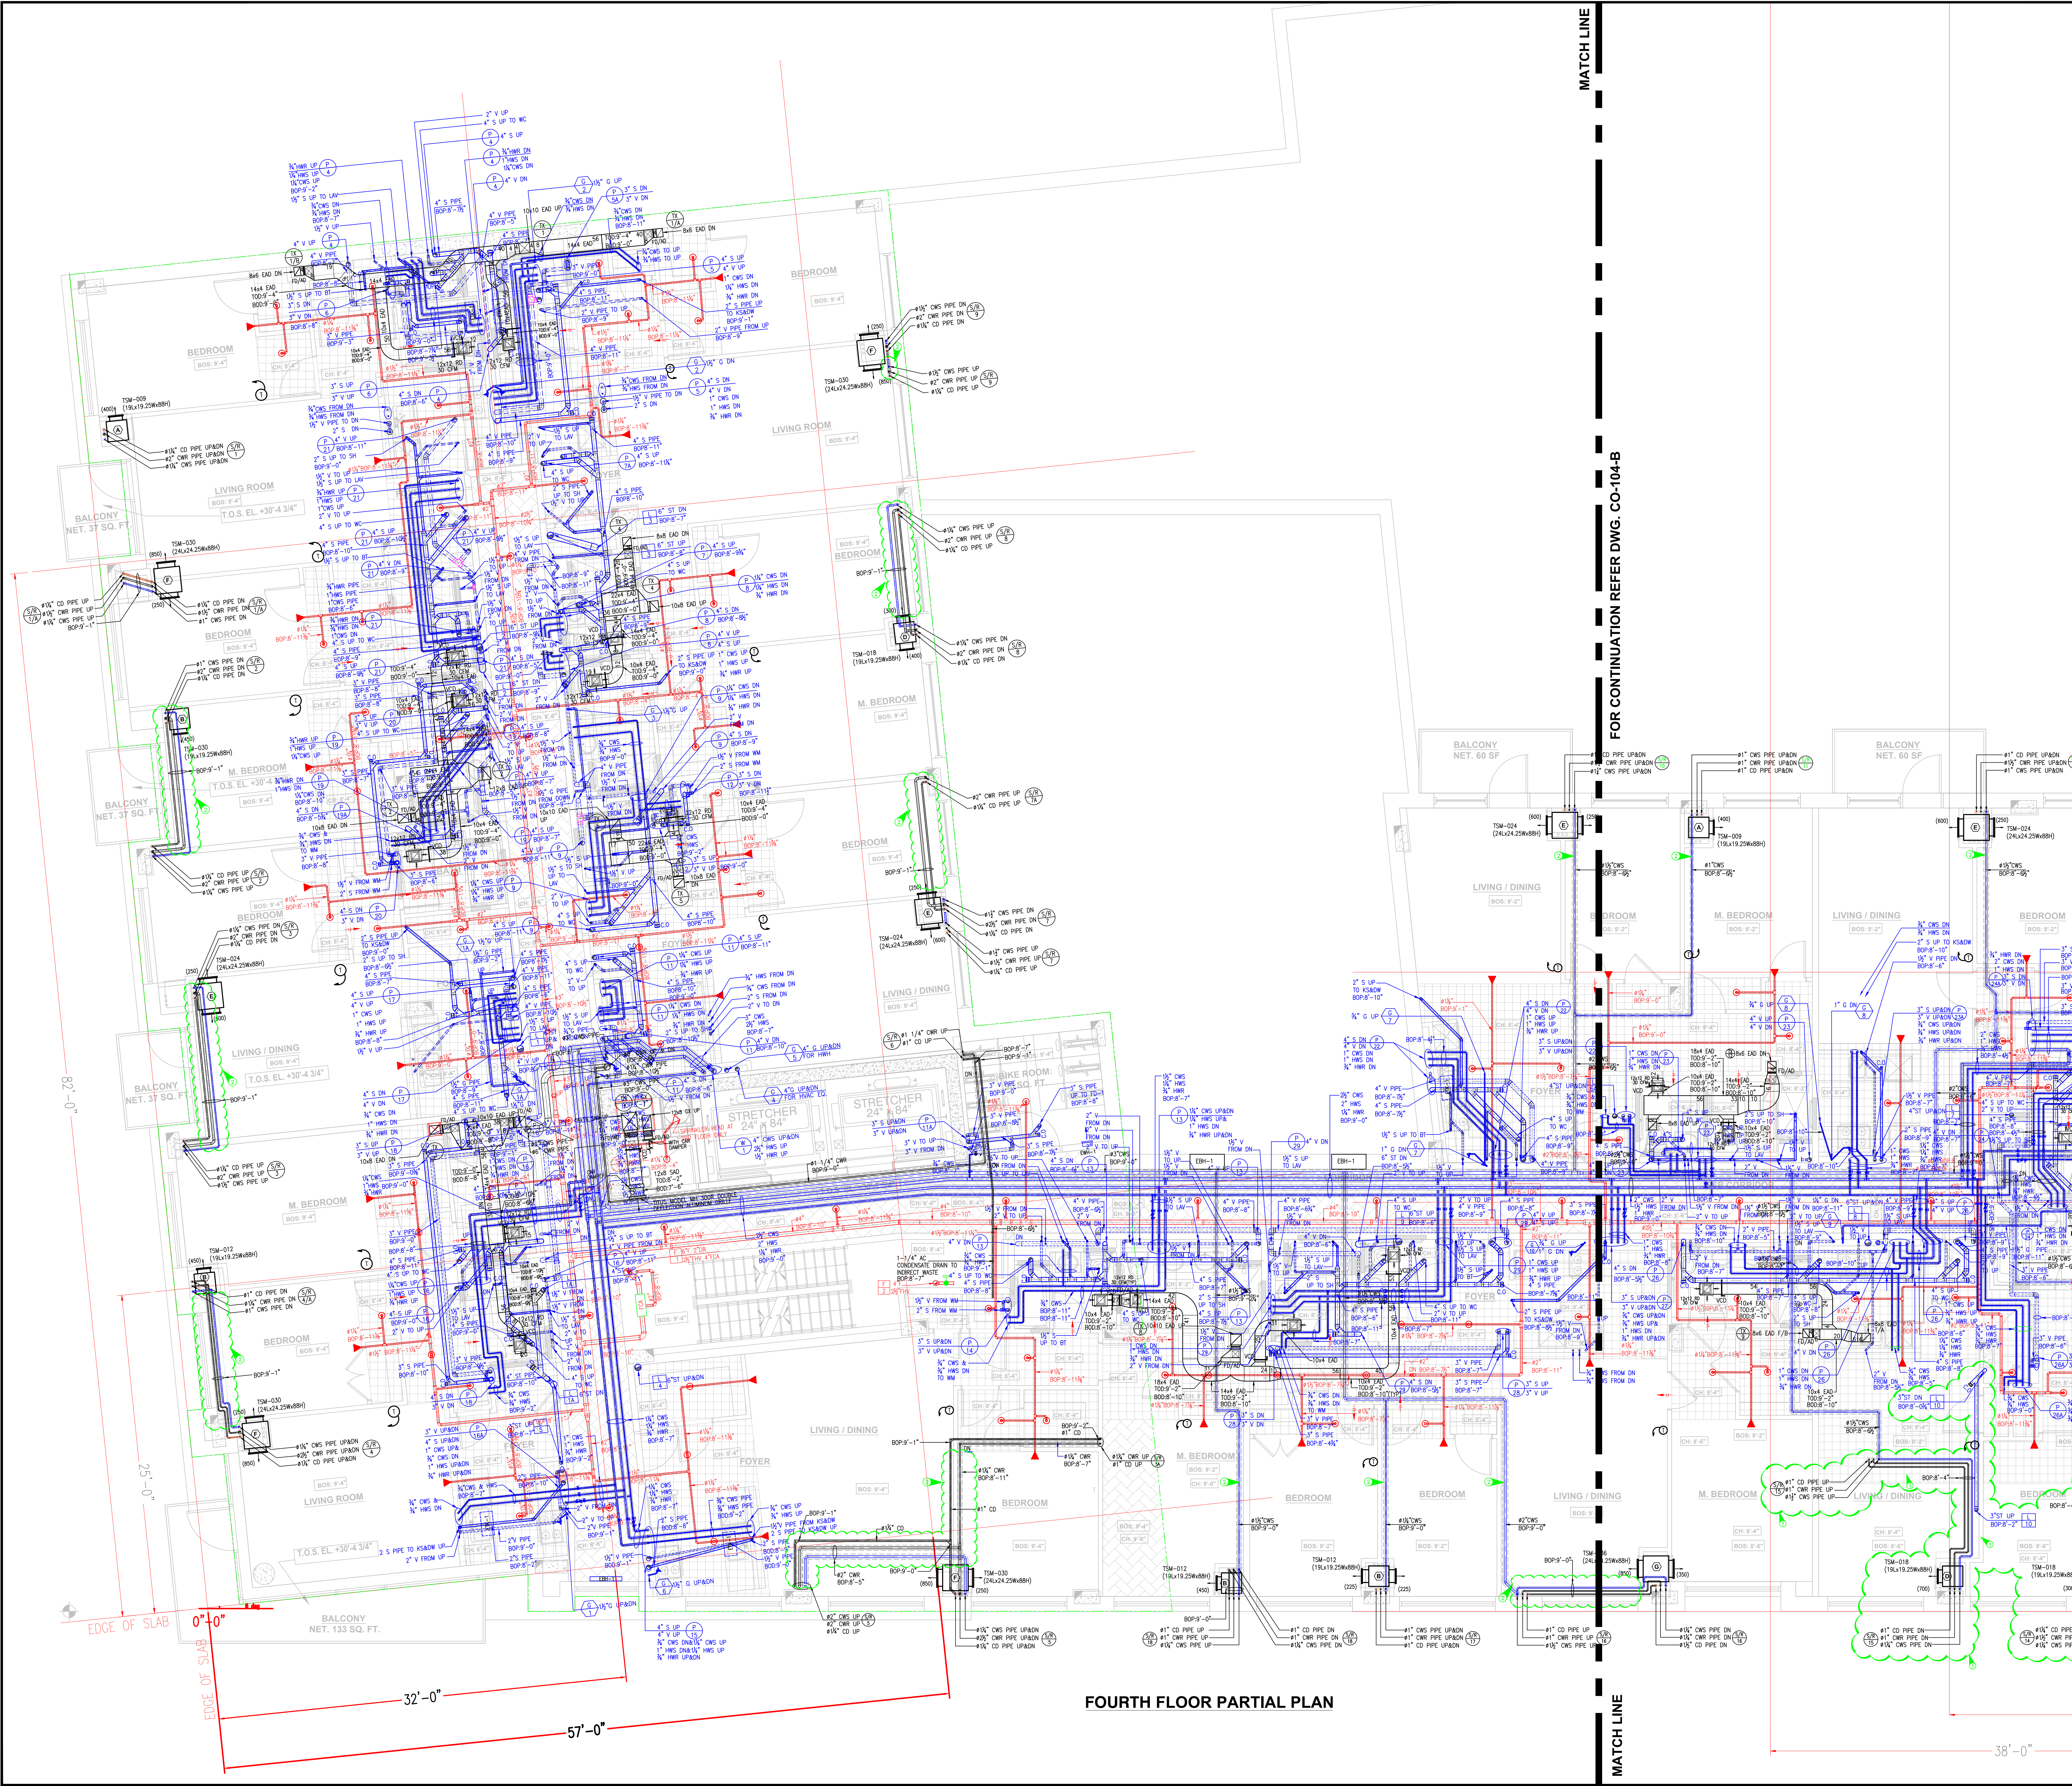

FOR CONTINUATION REFER DWG. CO-104-B

FOURTH FLOOR PARTIAL PLAN

THIS DRAWING IS A PRESENTATION OF A PROPOSED LAYOUT. IT IS THE CONTRACTORS RESPONSIBILITY TO VERIFY AND REVIEW PRIOR TO FINAL SUBMISSION. CADDSULTANTS IS NOT RESPONSIBLE FOR DISCREPANCY IN THE FIELD. ANY CORRECTIONS TO THE DRAWING IS REQUIRED BY THE CONTRACTOR TO ADVISE CADDSULTANTS BEFORE FINAL SUBMISSION & BEFORE FABRICATION OR INSTALLATION.

4	05/09/18	UPDATED AS PER COMMENTS.
3	04/20/18	REVISED AS PER NEW STRUCTURAL LEVEL.
2	03/14/18	REVISED AS PER COMMENTS DATED 03.05.18.
1	02/20/18	REVISED AS PER COMMENTS.
NO.	DATE:	DESCRIPTION:

PLUMBING CONTRACTOR:
Titan Realty & Construction
 One Plaza Road
 Greenvale, New York 11548
 T. 516-348-1200 x 143
 F. 516-348-1201
 E. Nawad@titannewyork.com


DRAFTING COMPANY:
CADDSULTANTS
 Certified CAD Specialist
 All Types of Drafting
MARC HOFFMAN
 167 Allen Road
 Rockville Centre, NY, 11570
 Contact: 646.651.2512
 Email: Caddsubstant@yahoo.com

ADDRESS:
NEW MIXED USE DEVELOPMENT
 575 4th AVENUE
 BROOKLYN, NY 11215

PROJECT INFORMATION:

Scale: 1/4"=1'-0"	02/02/18	Drawing Number
PAGE SIZE 36x48	CO-104A	

- ① Pipes are below the reflected ceiling.
- ② Hvac Pipes are exposed.

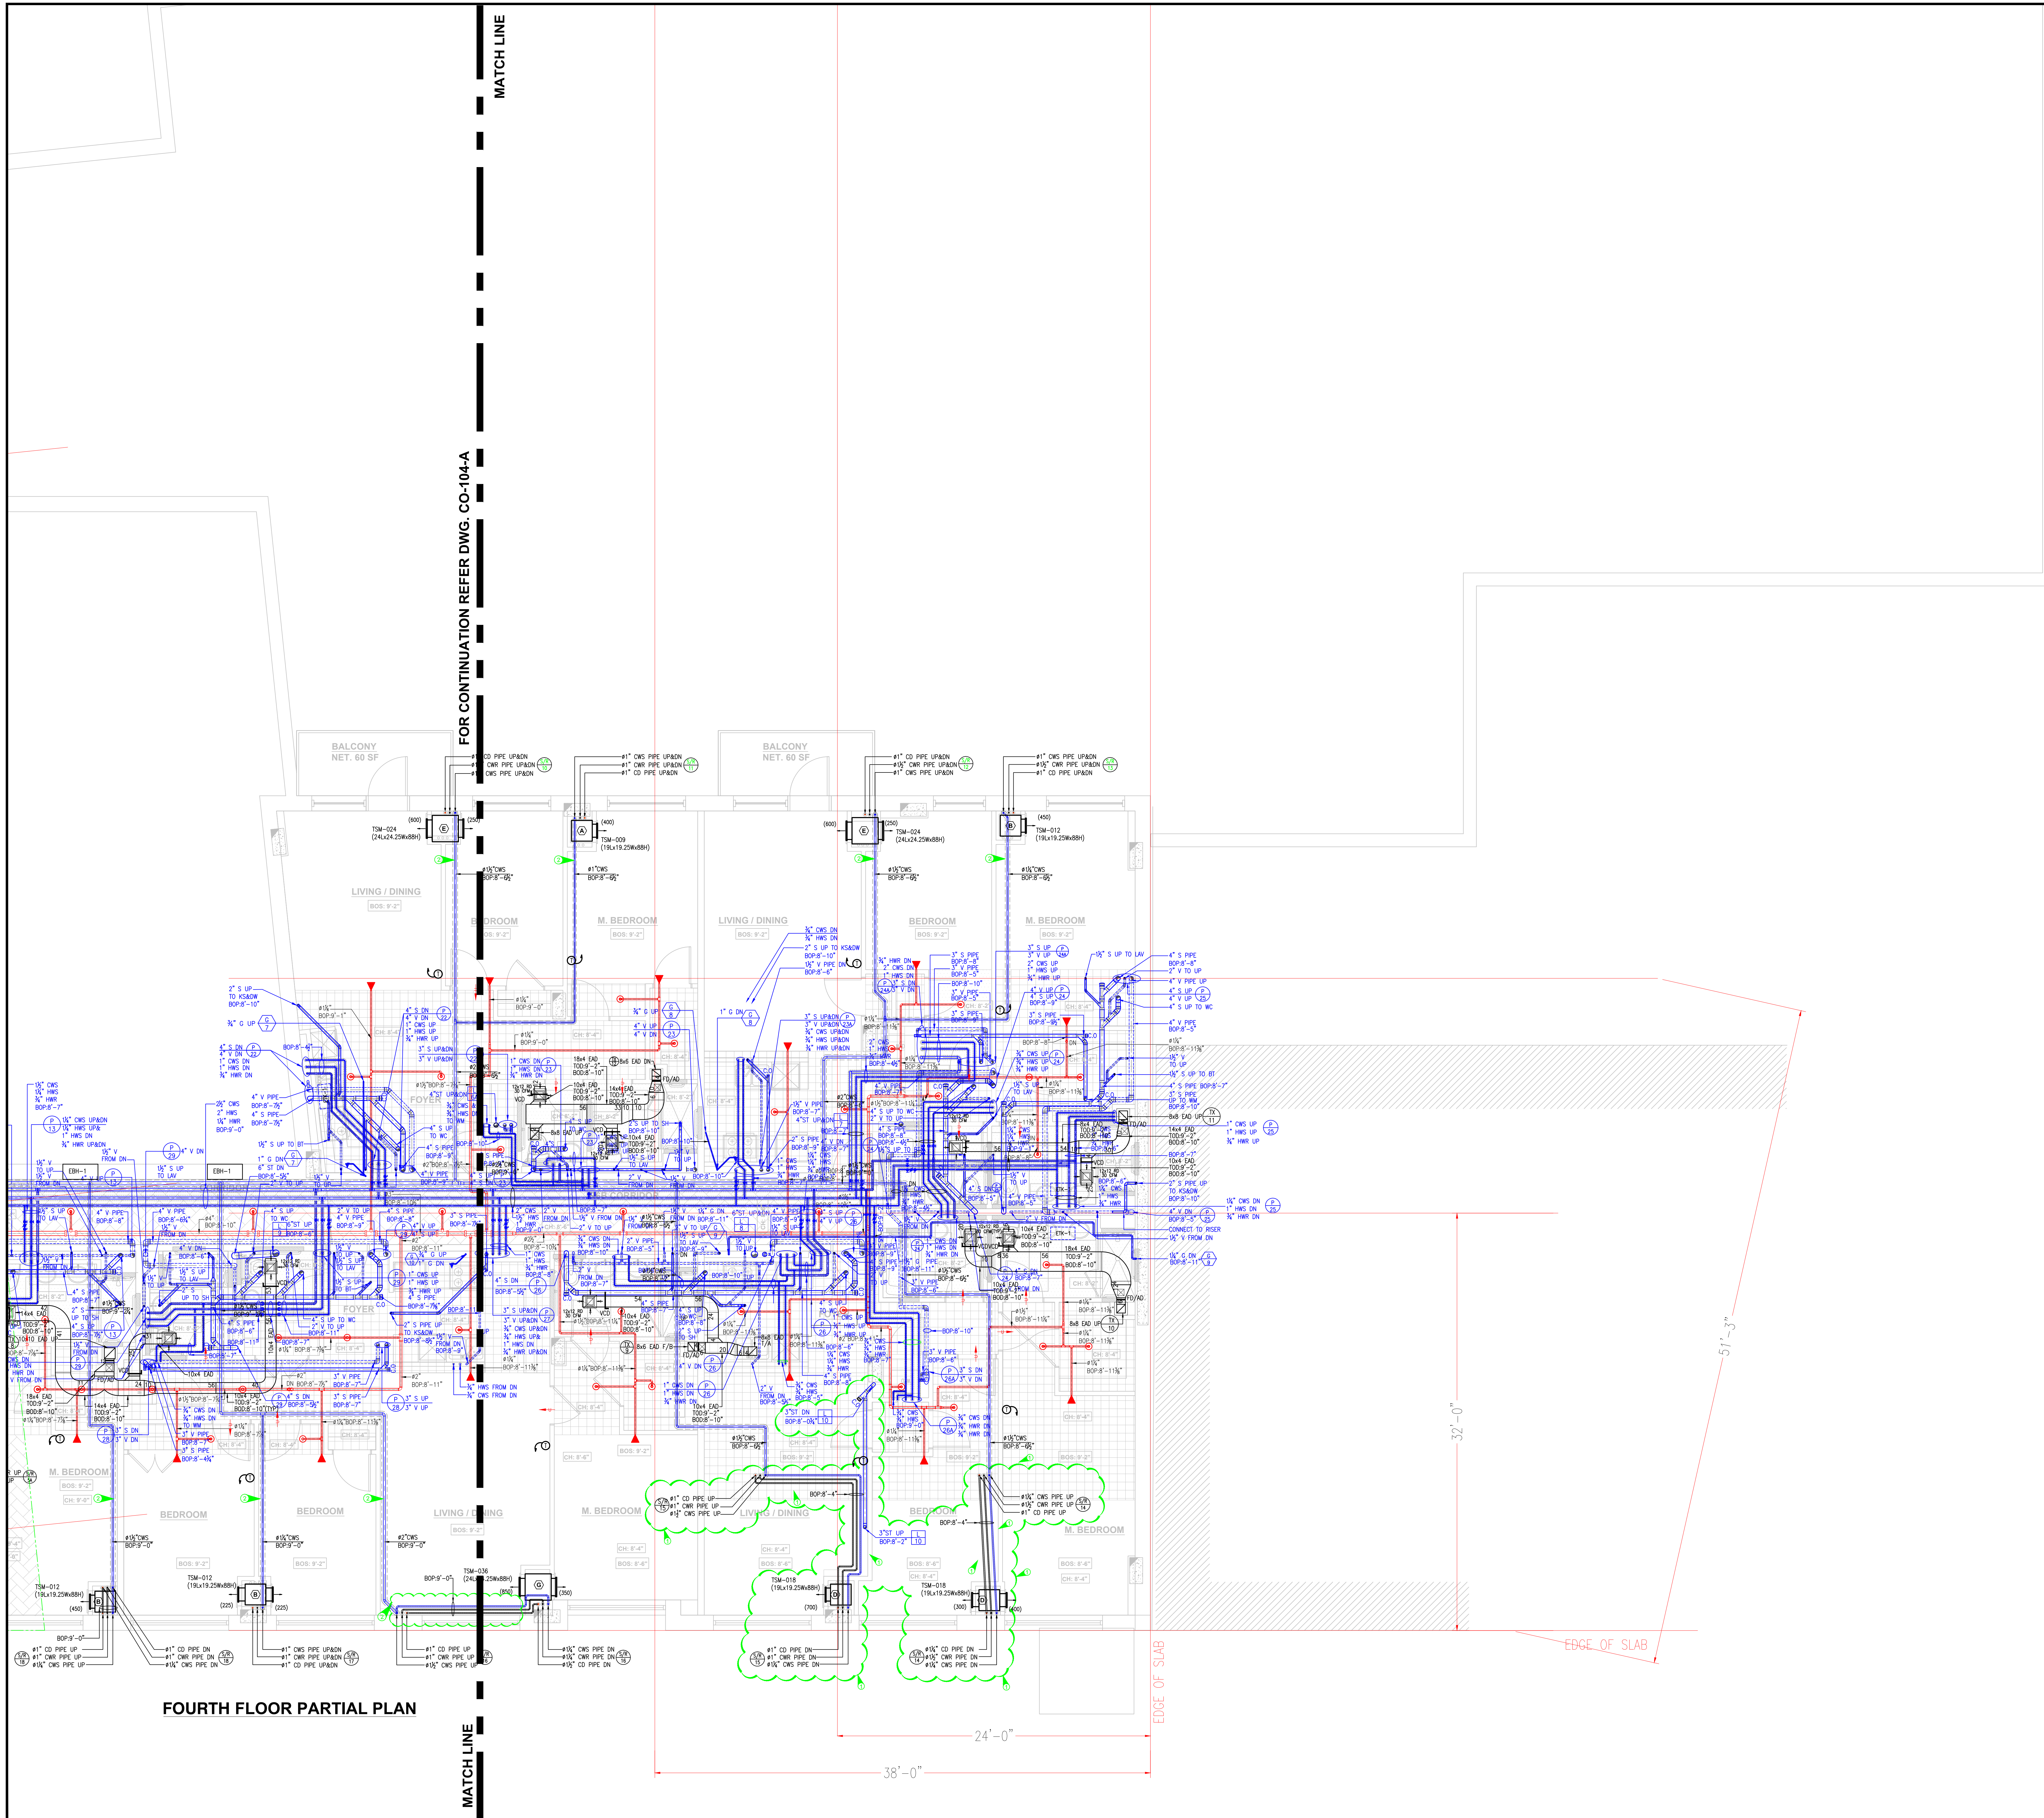

THIS DRAWING IS A PRESENTATION OF A PROPOSED LAYOUT. IT IS THE CONTRACTORS RESPONSIBILITY TO VERIFY AND REVIEW PRIOR TO FINAL SUBMISSION. CADDSULTANTS IS NOT RESPONSIBLE FOR DISCREPANCY IN THE FIELD. ANY CORRECTIONS TO THE DRAWING IS REQUIRED BY THE CONTRACTOR TO ADVISE CADDSULTANTS BEFORE FINAL SUBMISSION & BEFORE FABRICATION OR INSTALLATION.

NO.	DATE	DESCRIPTION
4	05/09/18	UPDATED AS PER COMMENTS.
3	04/20/18	REVISED AS PER NEW STRUCTURAL LEVEL.
2	03/14/18	REVISED AS PER COMMENTS DATED 03.05.18.
1	02/20/18	REVISED AS PER COMMENTS.

PLUMBING CONTRACTOR:
Titan Realty & Construction
 One Plaza Road
 Greenvale, New York 11548
 T. 516-348-1200 x 143
 F. 516-348-1201
 E. Nawad@titannewyork.com


DRAFTING COMPANY:
CADDSULTANTS
 Certified CAD Specialist
 All Types of Drafting
MARC HOFFMAN
 167 Allen Road
 Rockville Centre, NY, 11570
 Contact: 646.651.2512
 Email: Caddsubmittant@yahoo.com

ADDRESS:
NEW MIXED USE DEVELOPMENT
 575 4th AVENUE
 BROOKLYN, NY 11215

PROJECT INFORMATION:
**FOURTH FLOOR (PART-B)
 COMBINED SERVICES LAYOUT**



- ① Pipes are below the reflected ceiling.
- ② Hvac Pipes are exposed.

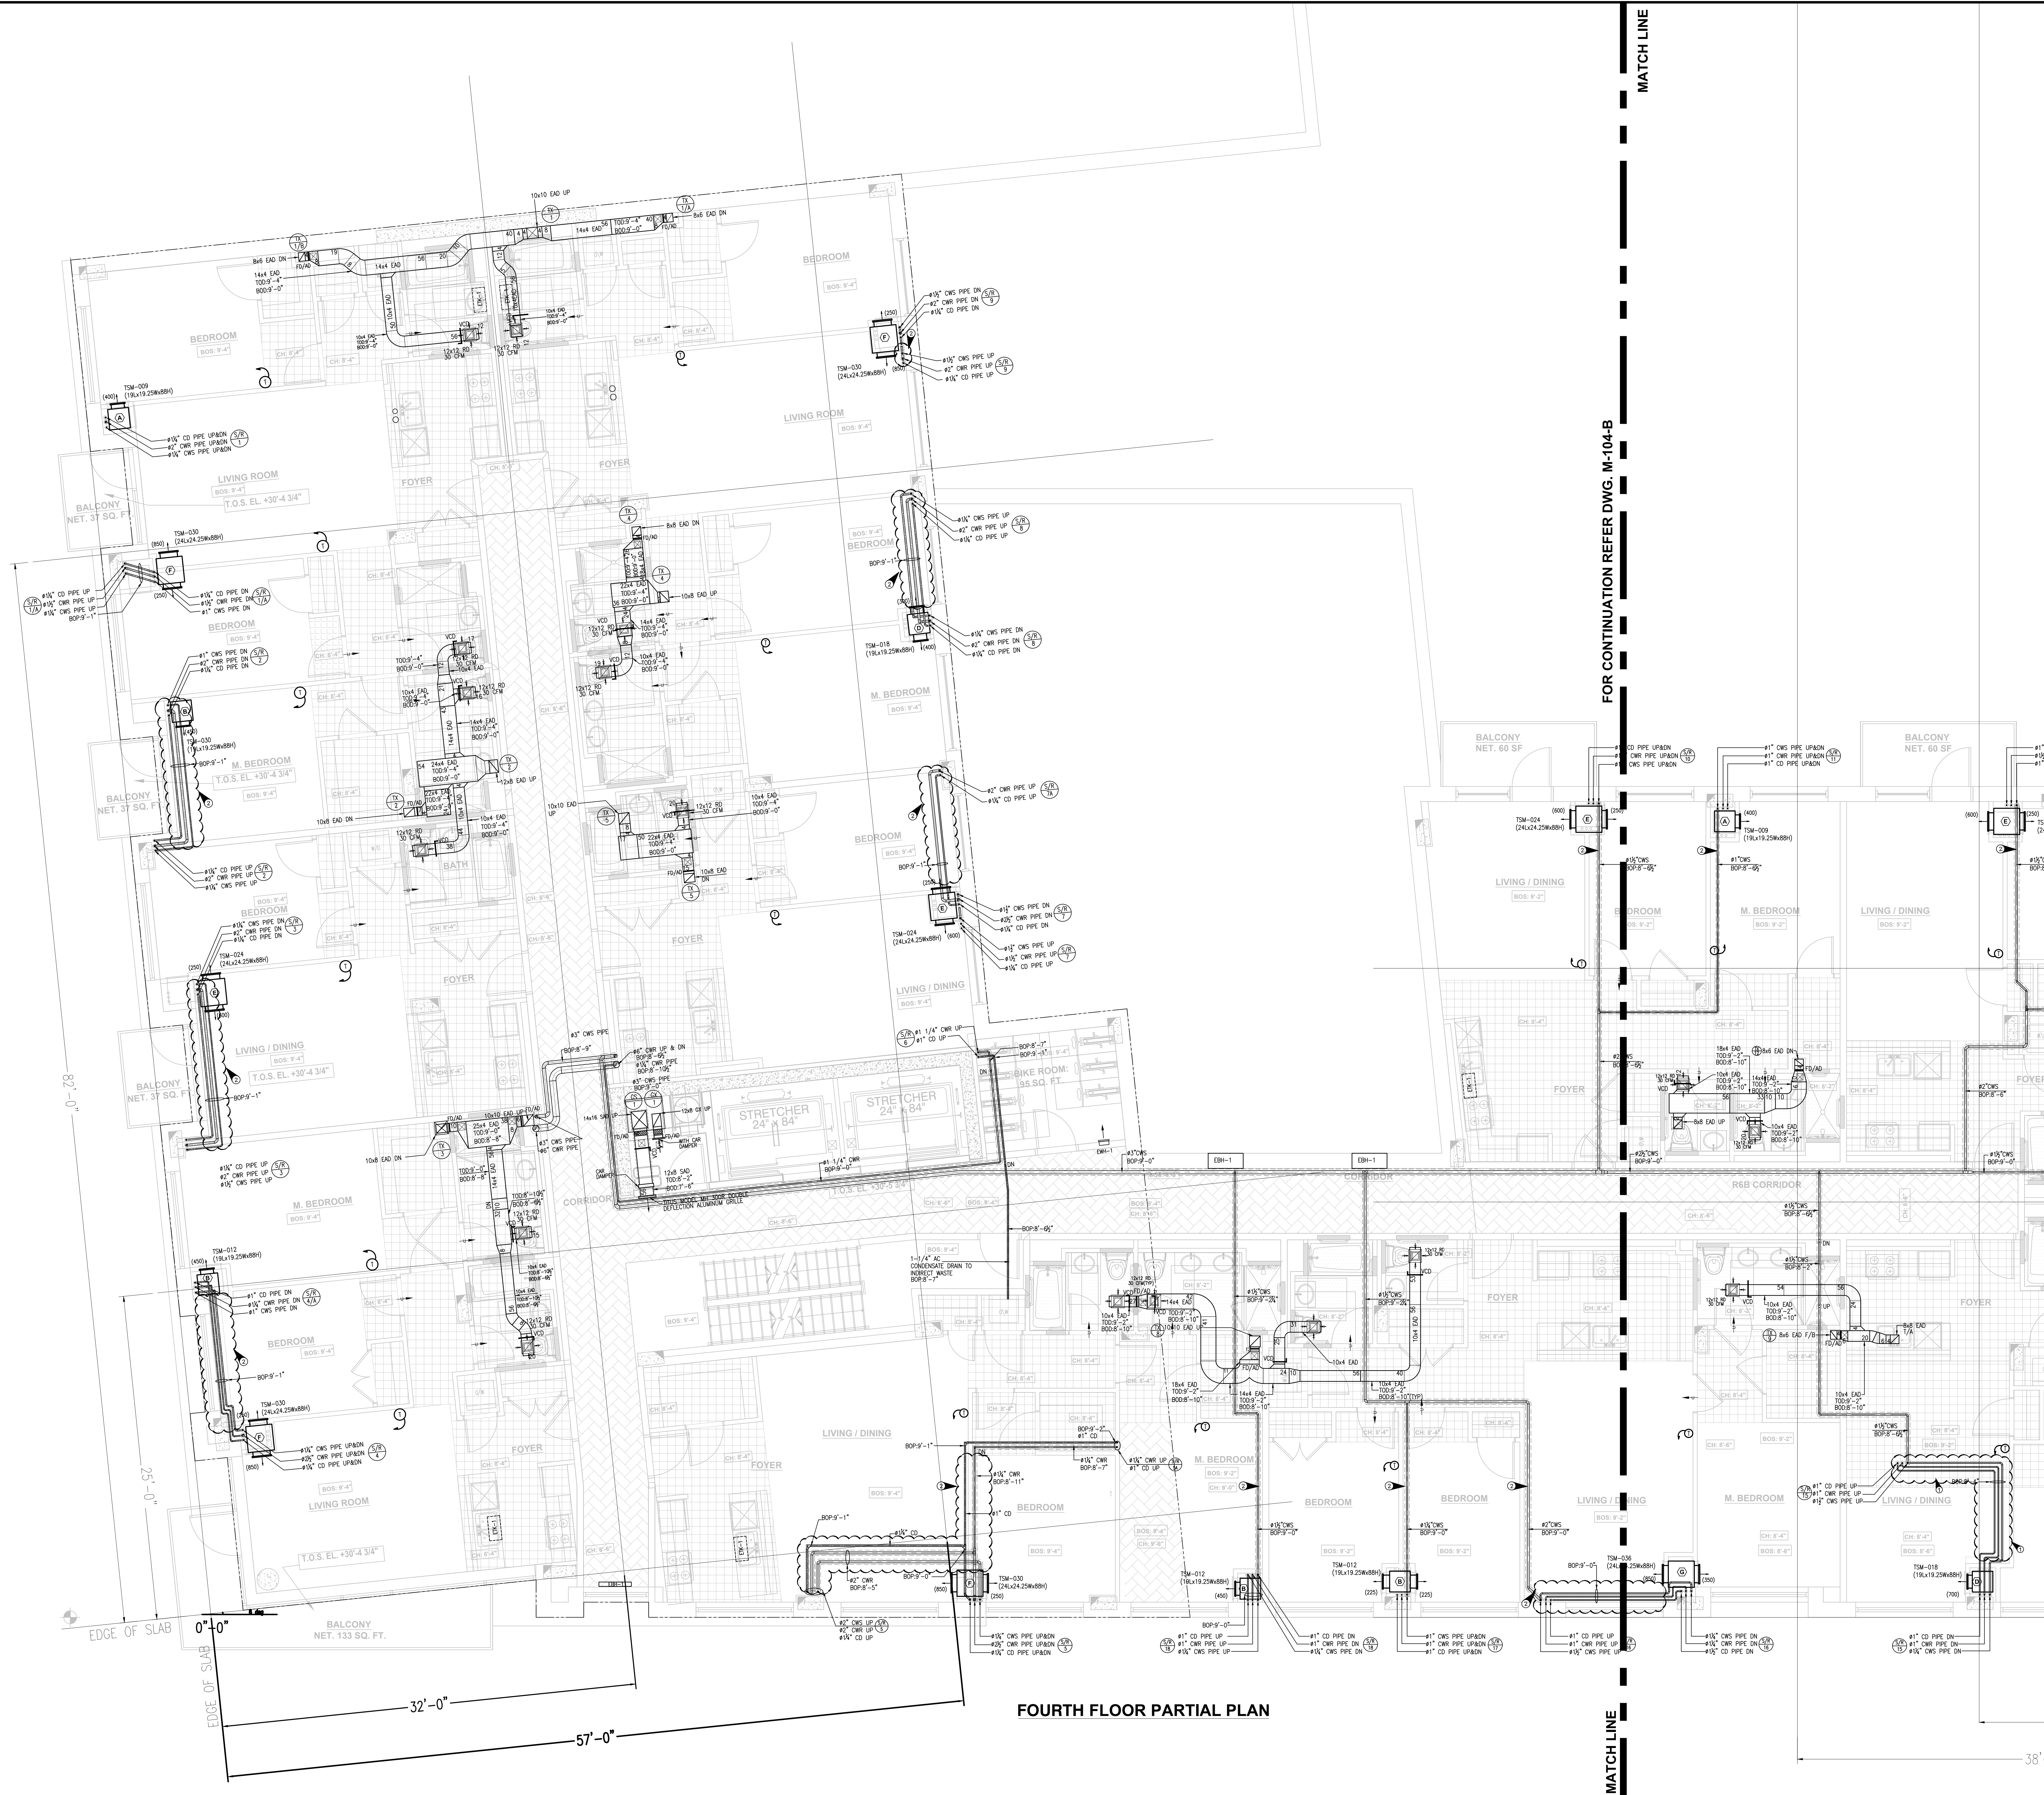

FOR CONTINUATION REFER DWG. M-104-B

MATCH LINE

MATCH LINE

FOURTH FLOOR PARTIAL PLAN

THIS DRAWING IS A PRESENTATION OF A PROPOSED LAYOUT. IT IS THE CONTRACTOR'S RESPONSIBILITY TO VERIFY AND REVIEW PRIOR TO FINAL SUBMISSION. CADDSULTANTS IS NOT RESPONSIBLE FOR DISCREPANCIES IN THE FIELD. ANY CORRECTIONS TO THE DRAWING IS REQUIRED BY THE CONTRACTOR TO ADVISE CADDSULTANTS BEFORE FINAL SUBMISSION & BEFORE FABRICATION OR INSTALLATION.

NO.	DATE	DESCRIPTION
4	05/09/18	UPDATED AS PER COMMENTS.
3	04/20/18	REVISED AS PER NEW STRUCTURAL LEVEL.
2	03/14/18	REVISED AS PER COMMENTS DATED 03/05/18.
1	02/20/18	REVISED AS PER COMMENTS.


PLUMBING CONTRACTOR:
Titan Realty & Construction
 One Plaza Road
 Greenvale, New York 11548
 T. 516-348-1200 x 143
 F. 516-348-1201
 E. Nawad@titannewyork.com

DRAFTING COMPANY:
CADDSULTANTS
 Certified CAD Specialist
 All Types of Drafting
MARC HOFFMAN
 167 Allen Road
 Rockville Centre, NY, 11570
 Contact: 646.651.2512
 Email: Caddsubmitt@yahoo.com

ADDRESS:
NEW MIXED USE DEVELOPMENT
 575 4th AVENUE
 BROOKLYN, NY 11215

PROJECT INFORMATION:
FOURTH FLOOR (PART - A)
HVAC DUCTING & PIPING LAYOUT
 Scale: 1/4"=1'-0" 02/02/18 Drawing Number
 PAGE SIZE 36x48 M-104A

- ① Pipes are below the reflected ceiling.
- ② Hvac Pipes are exposed.

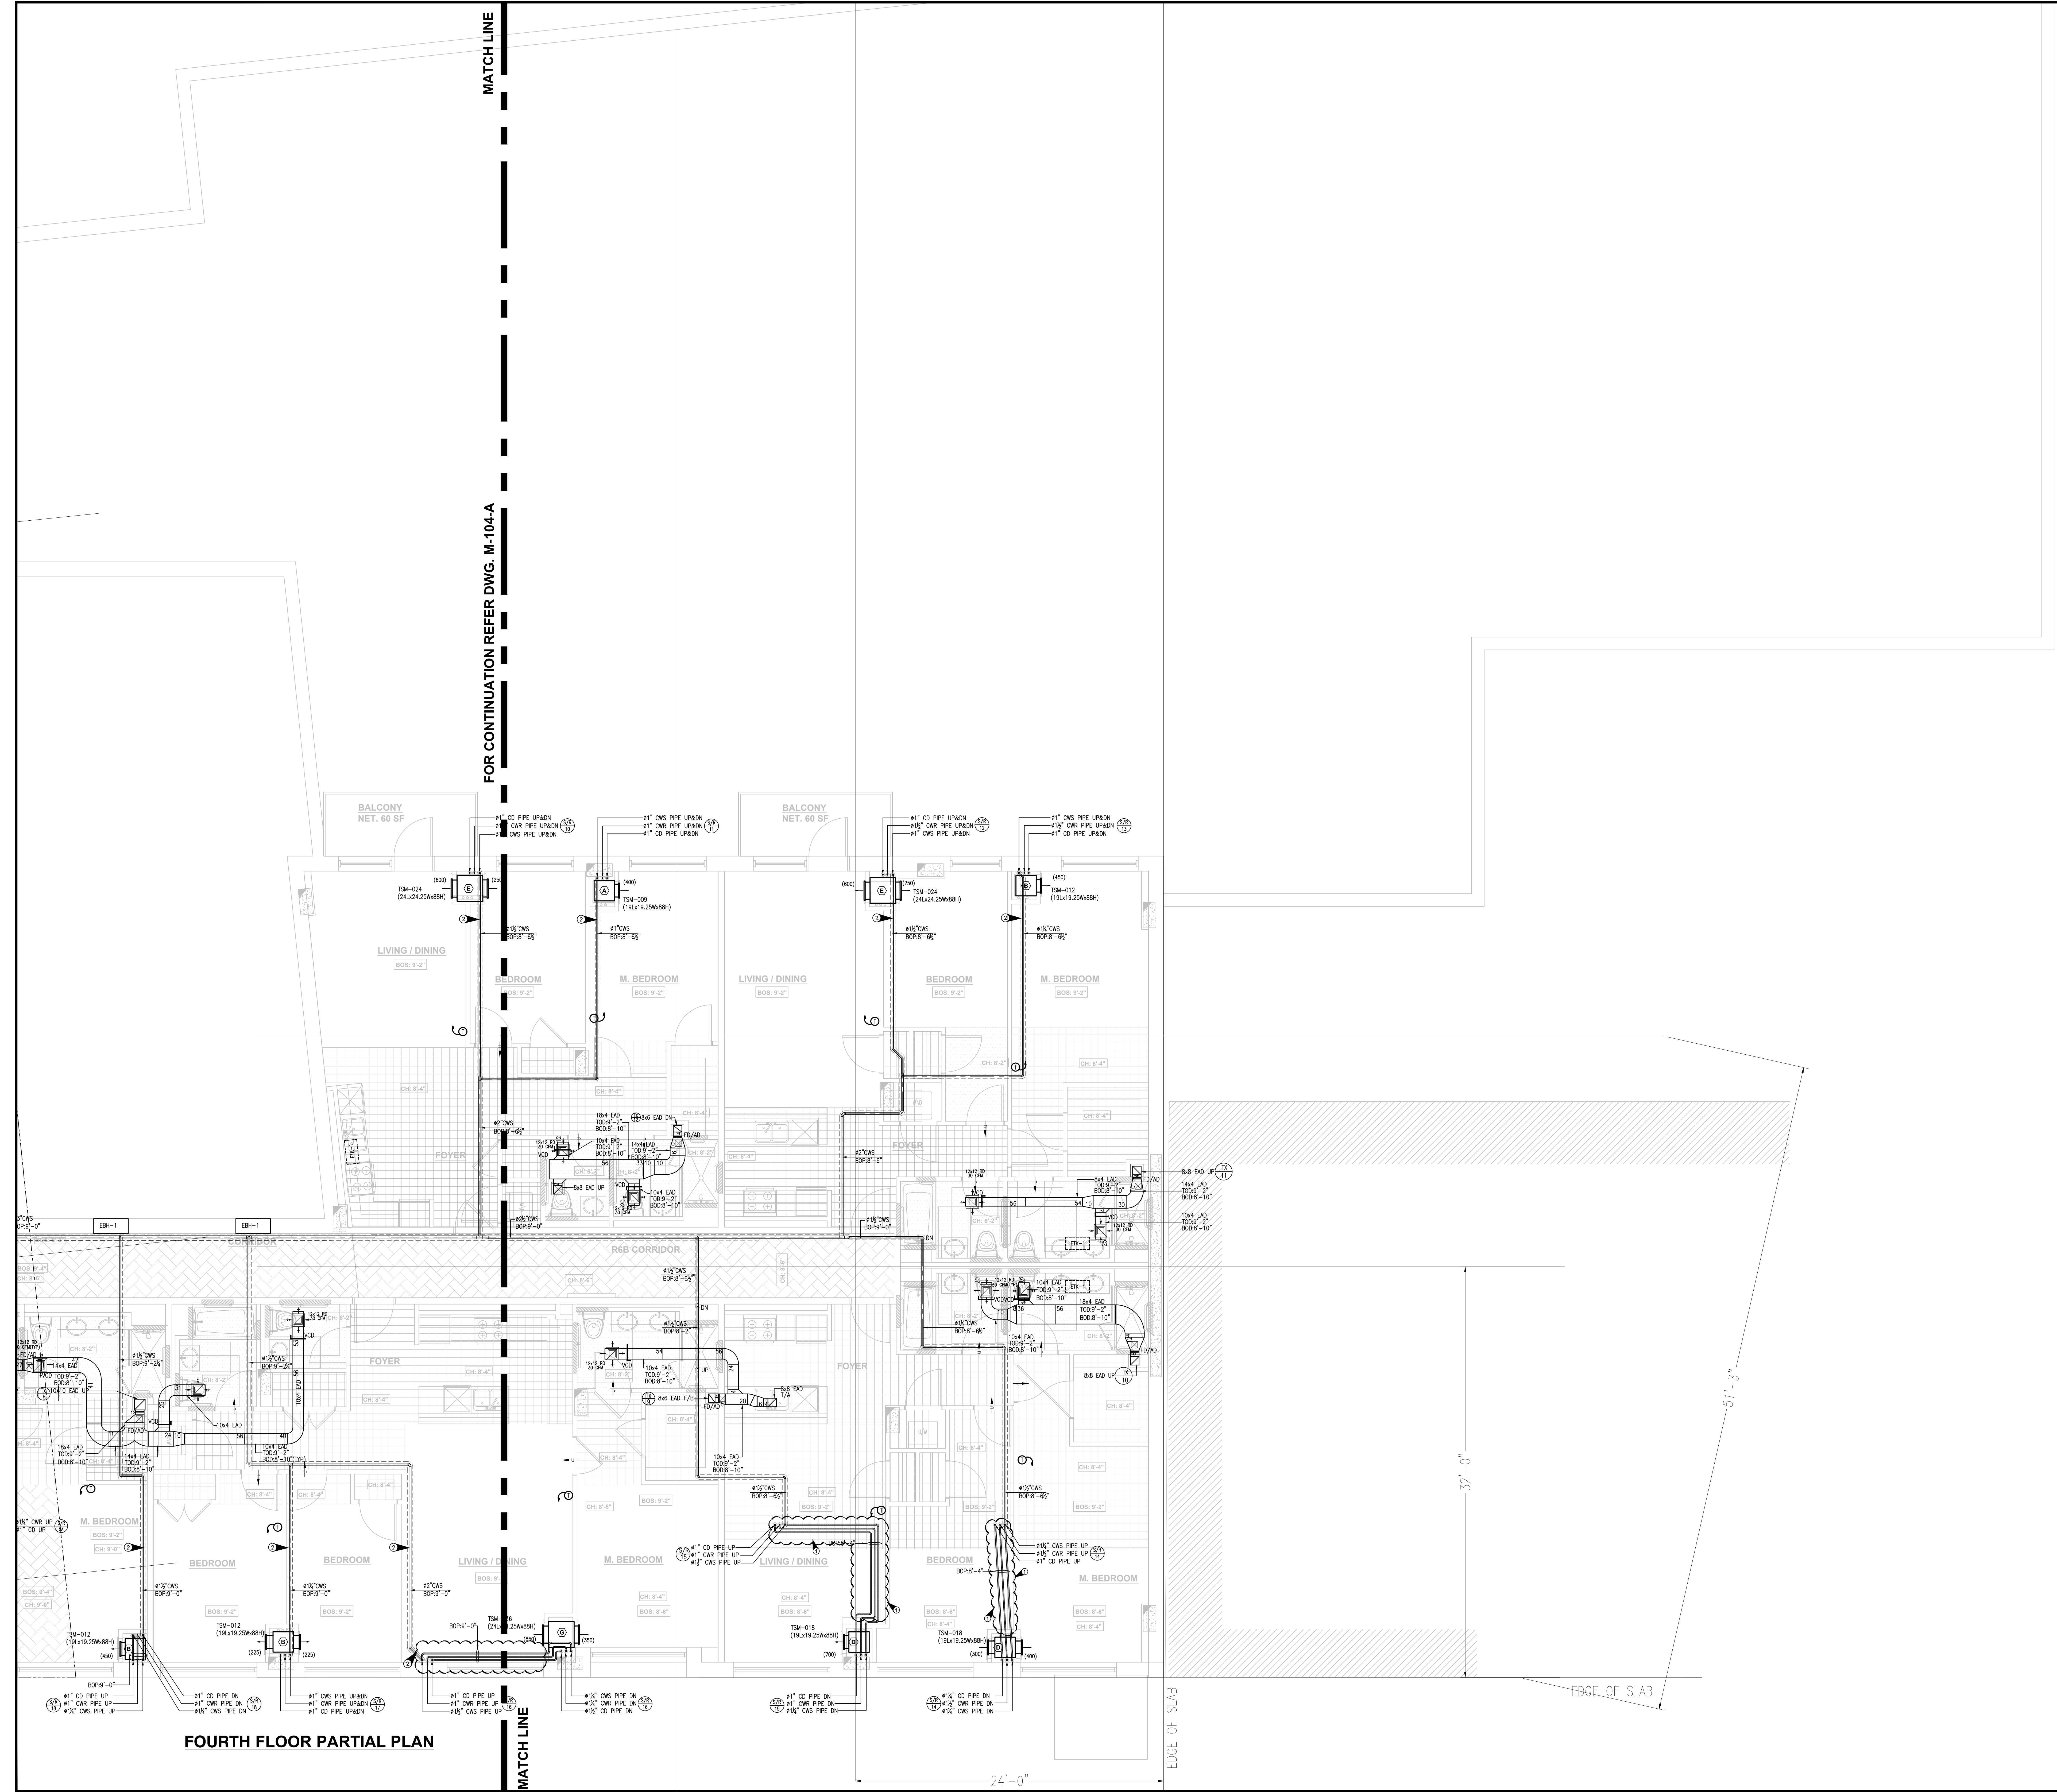

THIS DRAWING IS A PRESENTATION OF A PROPOSED LAYOUT. IT IS THE CONTRACTOR'S RESPONSIBILITY TO VERIFY AND REVIEW PRIOR TO FINAL SUBMISSION. CADDSULTANTS IS NOT RESPONSIBLE FOR DISCREPANCIES IN THE FIELD. ANY CORRECTIONS TO THE DRAWING IS REQUIRED BY THE CONTRACTOR TO ADVISE CADDSULTANTS BEFORE FINAL SUBMISSION & BEFORE FABRICATION OR INSTALLATION.

NO.	DATE	DESCRIPTION
4	05/09/18	UPDATED AS PER COMMENTS.
3	04/20/18	REVISED AS PER NEW STRUCTURAL LEVEL.
2	03/14/18	REVISED AS PER COMMENTS DATED 03.05.18.
1	02/20/18	REVISED AS PER COMMENTS.

PLUMBING CONTRACTOR:
Titan Realty & Construction
 One Plaza Road
 Greenvale, New York 11548
 T. 516-348-1200 x 143
 F. 516-348-1201
 E. Nawad@titannewyork.com

DRAFTING COMPANY:
CADDSULTANTS
 Certified CAD Specialist
 All Types of Drafting
MARC HOFFMAN
 167 Allen Road
 Rockville Centre, NY, 11570
 Contact: 646.651.2512
 Email: Caddsubtants@yahoo.com

ADDRESS:
NEW MIXED USE DEVELOPMENT
 575 4th AVENUE
 BROOKLYN, NY 11215

PROJECT INFORMATION:
**FOURTH FLOOR (PART - B)
 HVAC DUCTING & PIPING LAYOUT**



MATCH LINE

FOR CONTINUATION REFER DWG. SP-104-B

MATCH LINE

THIS DRAWING IS A PRESENTATION OF A PROPOSED LAYOUT. IT IS THE CONTRACTOR'S RESPONSIBILITY TO VERIFY AND REVIEW PRIOR TO FINAL SUBMISSION. CADDSULTANTS IS NOT RESPONSIBLE FOR DISCREPANCIES IN THE FIELD. ANY CORRECTIONS TO THE DRAWING IS REQUIRED BY THE CONTRACTOR TO ADVISE CADDSULTANTS BEFORE FINAL SUBMISSION & BEFORE FABRICATION OR INSTALLATION.

NO.	DATE	DESCRIPTION
4	05/09/18	UPDATED AS PER COMMENTS.
3	04/20/18	REVISED AS PER NEW STRUCTURAL LEVEL.
2	03/14/18	REVISED AS PER COMMENTS DATED 03.05.18.
1	02/20/18	REVISED AS PER COMMENTS.

PLUMBING CONTRACTOR:
Titan Realty & Construction
 One Plaza Road
 Greenvale, New York 11548
 T. 516-348-1200 x 143
 F. 516-348-1201
 E. Nawad@titannewyork.com

DRAFTING COMPANY:
CADDSULTANTS
 Certified CAD Specialist
 All Types of Drafting
MARC HOFFMAN
 167 Allen Road
 Rockville Centre, NY, 11570
 Contact: 646.651.2512
 Email: Caddsublunt@yahoo.com

ADDRESS:
NEW MIXED USE DEVELOPMENT
 575 4th AVENUE
 BROOKLYN, 11215

PROJECT INFORMATION:
**FOURTH FLOOR (PART-A)
 SPRINKLER PLAN**

FOURTH FLOOR PARTIAL PLAN



FOR CONTINUATION REFER DWG. SP-104-A

MATCH LINE

FOURTH FLOOR PARTIAL PLAN

THIS DRAWING IS A PRESENTATION OF A PROPOSED LAYOUT. IT IS THE CONTRACTOR'S RESPONSIBILITY TO VERIFY AND REVIEW PRIOR TO FINAL SUBMISSION. CADDSULTANTS IS NOT RESPONSIBLE FOR DISCREPANCIES IN THE FIELD. ANY CORRECTIONS TO THE DRAWING IS REQUIRED BY THE CONTRACTOR TO ADVISE CADDSULTANTS BEFORE FINAL SUBMISSION & BEFORE FABRICATION OR INSTALLATION.

NO.	DATE	DESCRIPTION
4	05/09/18	UPDATED AS PER COMMENTS.
3	04/20/18	REVISED AS PER NEW STRUCTURAL LEVEL.
2	03/14/18	REVISED AS PER COMMENTS DATED 03.05.18.
1	02/20/18	REVISED AS PER COMMENTS.

PLUMBING CONTRACTOR:
Titan Realty & Construction
 One Plaza Road
 Greenvale, New York 11548
 T. 516-348-1200 x 143
 F. 516-348-1201
 E. Nawad@titannewyork.com

DRAFTING COMPANY:
CADDSULTANTS
 Certified CAD Specialist
 All Types of Drafting
MARC HOFFMAN
 167 Allen Road
 Rockville Centre, NY, 11570
 Contact: 646.651.2512
 Email: Caddsultant@yahoo.com

ADDRESS:
NEW MIXED USE DEVELOPMENT
 575 4th AVENUE
 BROOKLYN, 11215

PROJECT INFORMATION:
FOURTH FLOOR (PART-B)
SPRINKLER PLAN