


- NOTES:
1. ROUND SUPPLY DUCTS, NO INTERNAL LINER. SHOW EXTERNAL DUCT WRAP.
  2. ALL SUPPLY DIFFUSERS HAVE COD WITHIN 24".

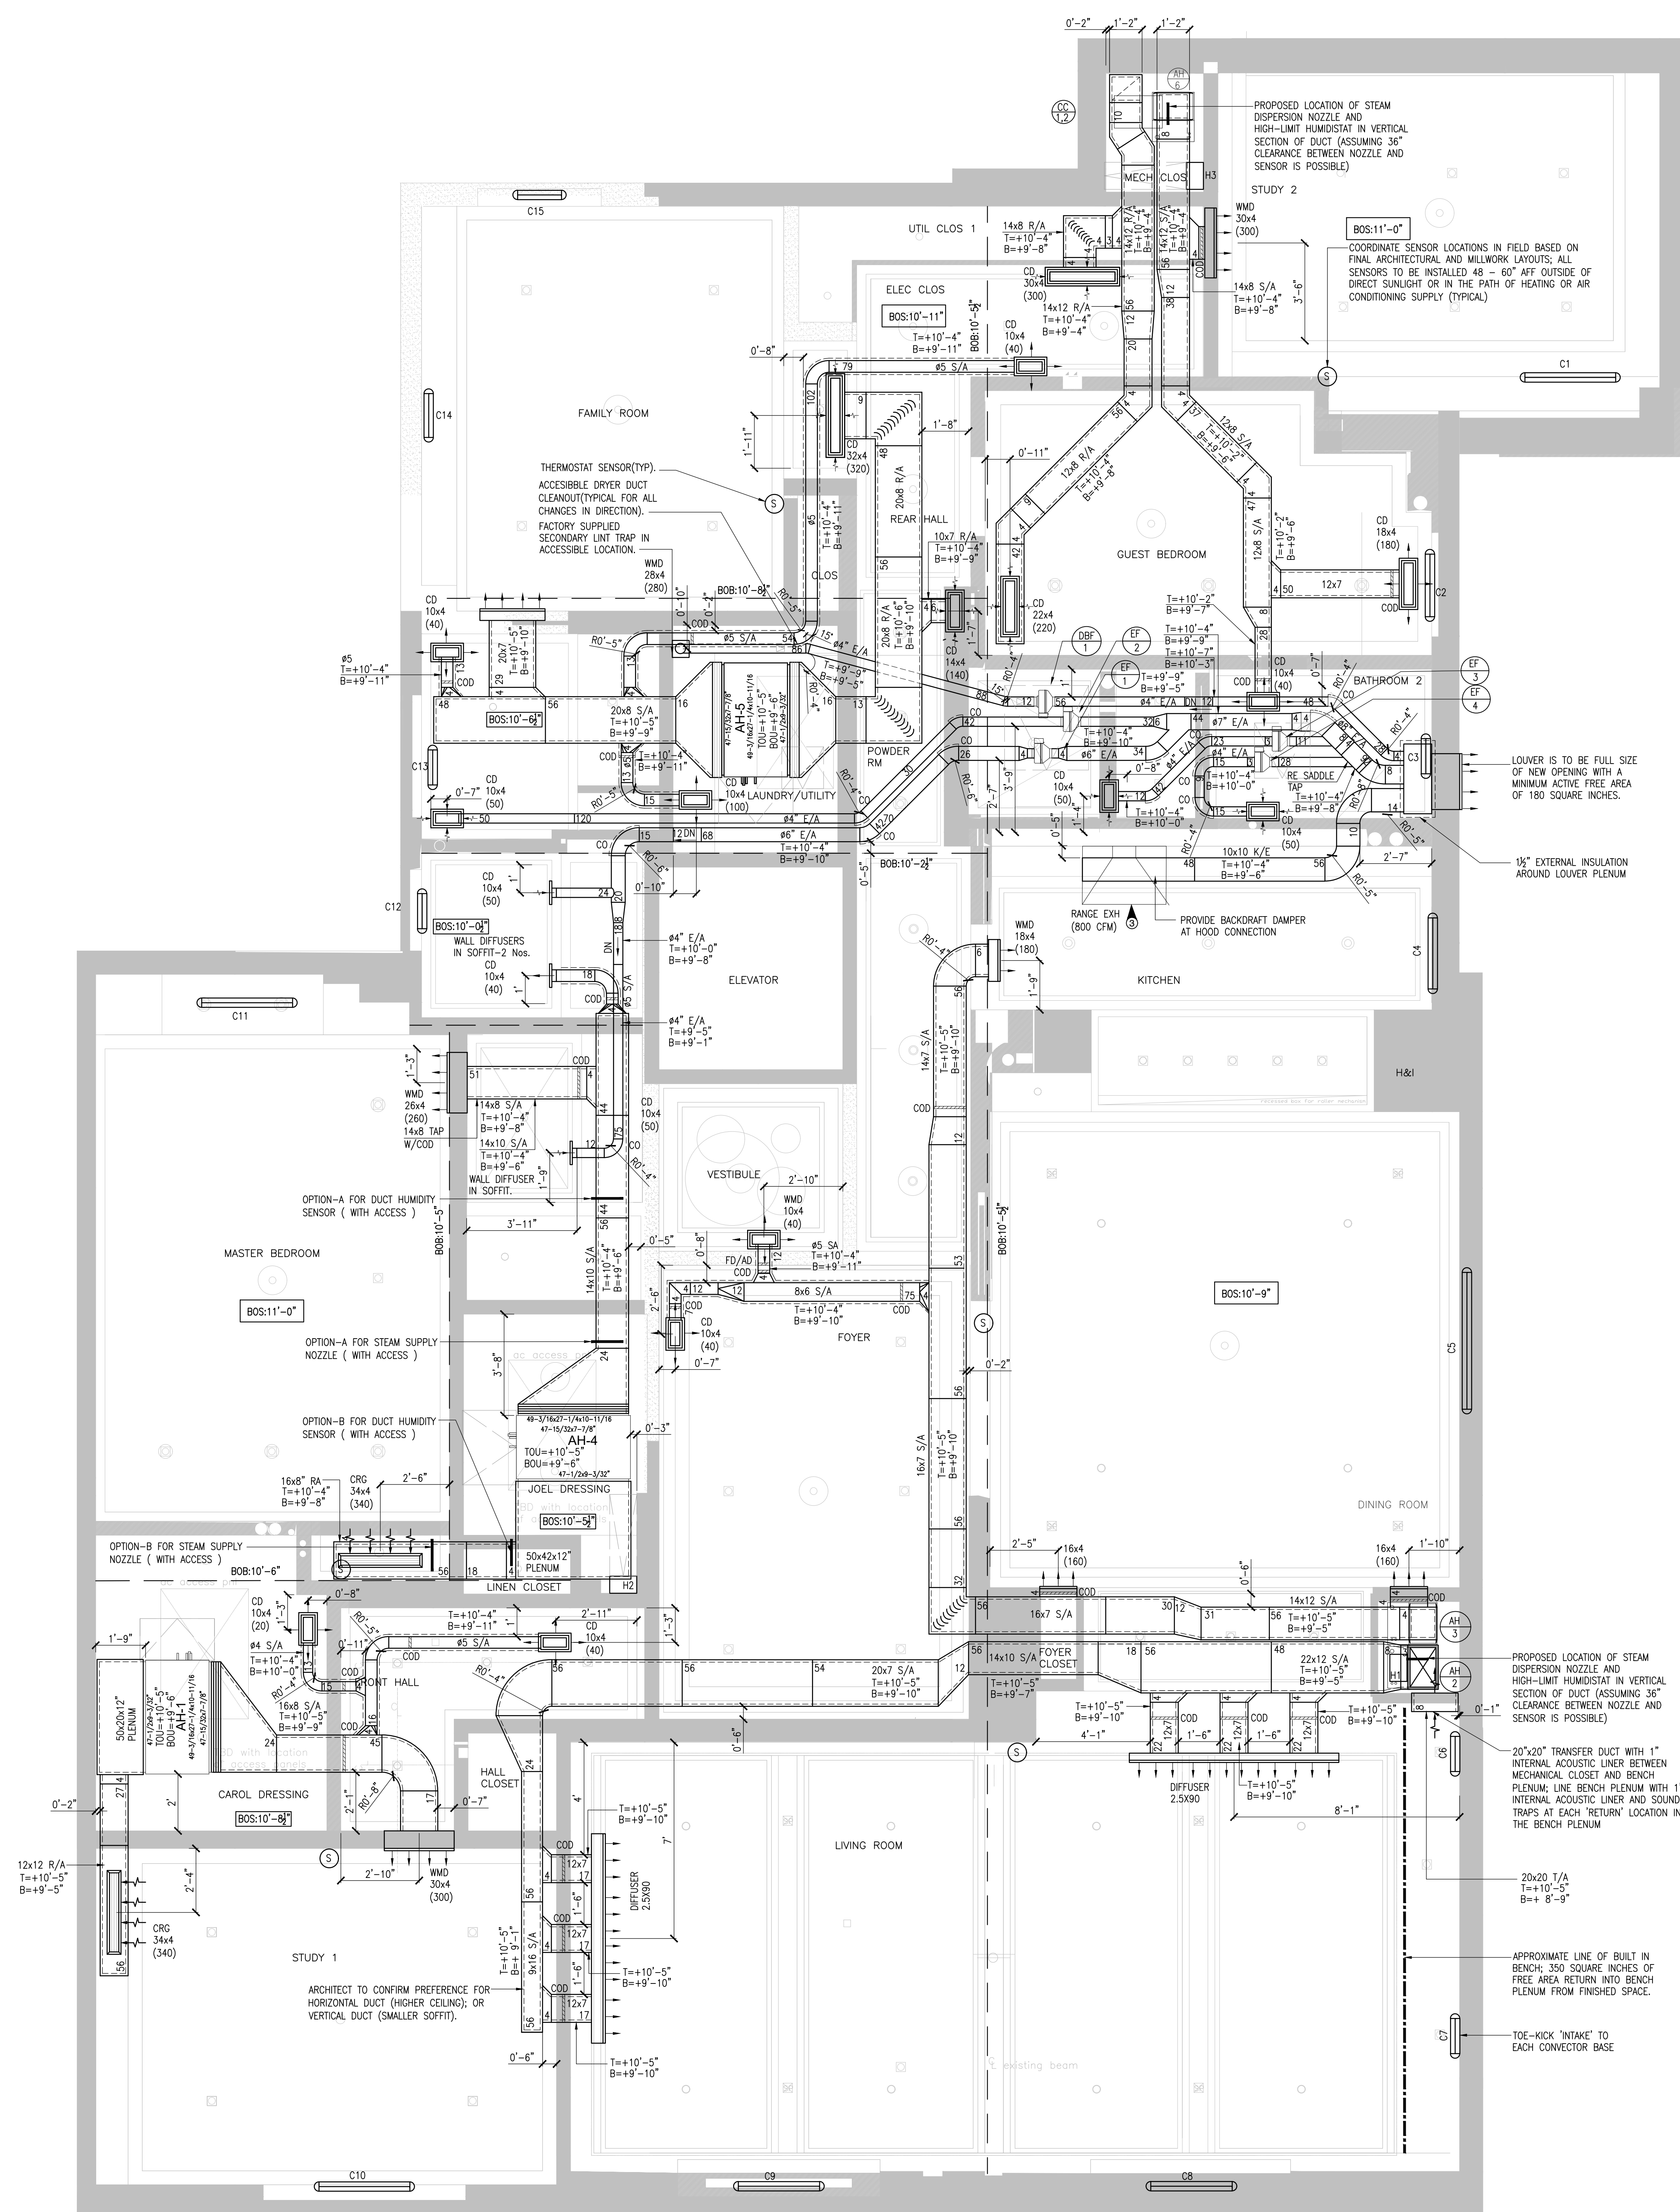

1 MECHANICAL-FIFTH FLOOR PLAN  
SCALE: 3/8"=1'-0"

THIS DRAWING IS A PRESENTATION OF A PROPOSED LAYOUT. IT IS THE CONTRACTOR'S RESPONSIBILITY TO VERIFY AND REVIEW PRIOR TO FINAL SUBMISSION. CADDSULTANTS IS NOT RESPONSIBLE FOR DISCREPANCY'S IN THE FIELD. ANY CORRECTIONS TO THE DRAWING IS REQUIRED BY THE CONTRACTOR TO ADVISE CADDSULTANTS BEFORE FINAL SUBMISSION & BEFORE FABRICATION OR INSTALLATION.

NO.	DATE	DESCRIPTION
6	06.10.19	Revised as per comments.
5	06.03.19	Revised as per comments.
4	05.10.19	Revised as per comments.
3	04.29.19	Revised as per comments.
2	04.26.19	Revised as per comments.
1	04.24.19	Updated as per markup

REVISIONS:

HVAC CONTRACTOR:

**INTEGRATE COMFORT SYSTEMS INC**  
267 CORTLAND ST  
BELLEVILLE, NJ 07109

DRAFTING COMPANY:

**CADDSULTANTS**  
Certified CAD Specialist  
All Types of Drafting

MARC HOFFMAN

167 Allen Road  
Rockville Centre NY, 11570  
Contact: 646.641.2512  
Email: Caddsubtant@yahoo.com

ADDRESS:

DAVIS MARCUS RESIDENCE  
88 CENTRAL PARK WEST 5S  
NEW YORK, NY

PROJECT INFORMATION:

FIFTH FLOOR  
MECHANICAL LAYOUT